



SET
AIR FORCE 1



DESCRIPTION
STAFF OFFICE CEILING - REFLECTED PLAN

STAGE / LOCATION
LONGCROSS - STAGE A

DATE
24. 03. 2023


SCALE
SCALE - 1:10 & F5 - PRINTED @ A0

DWG#
333-012

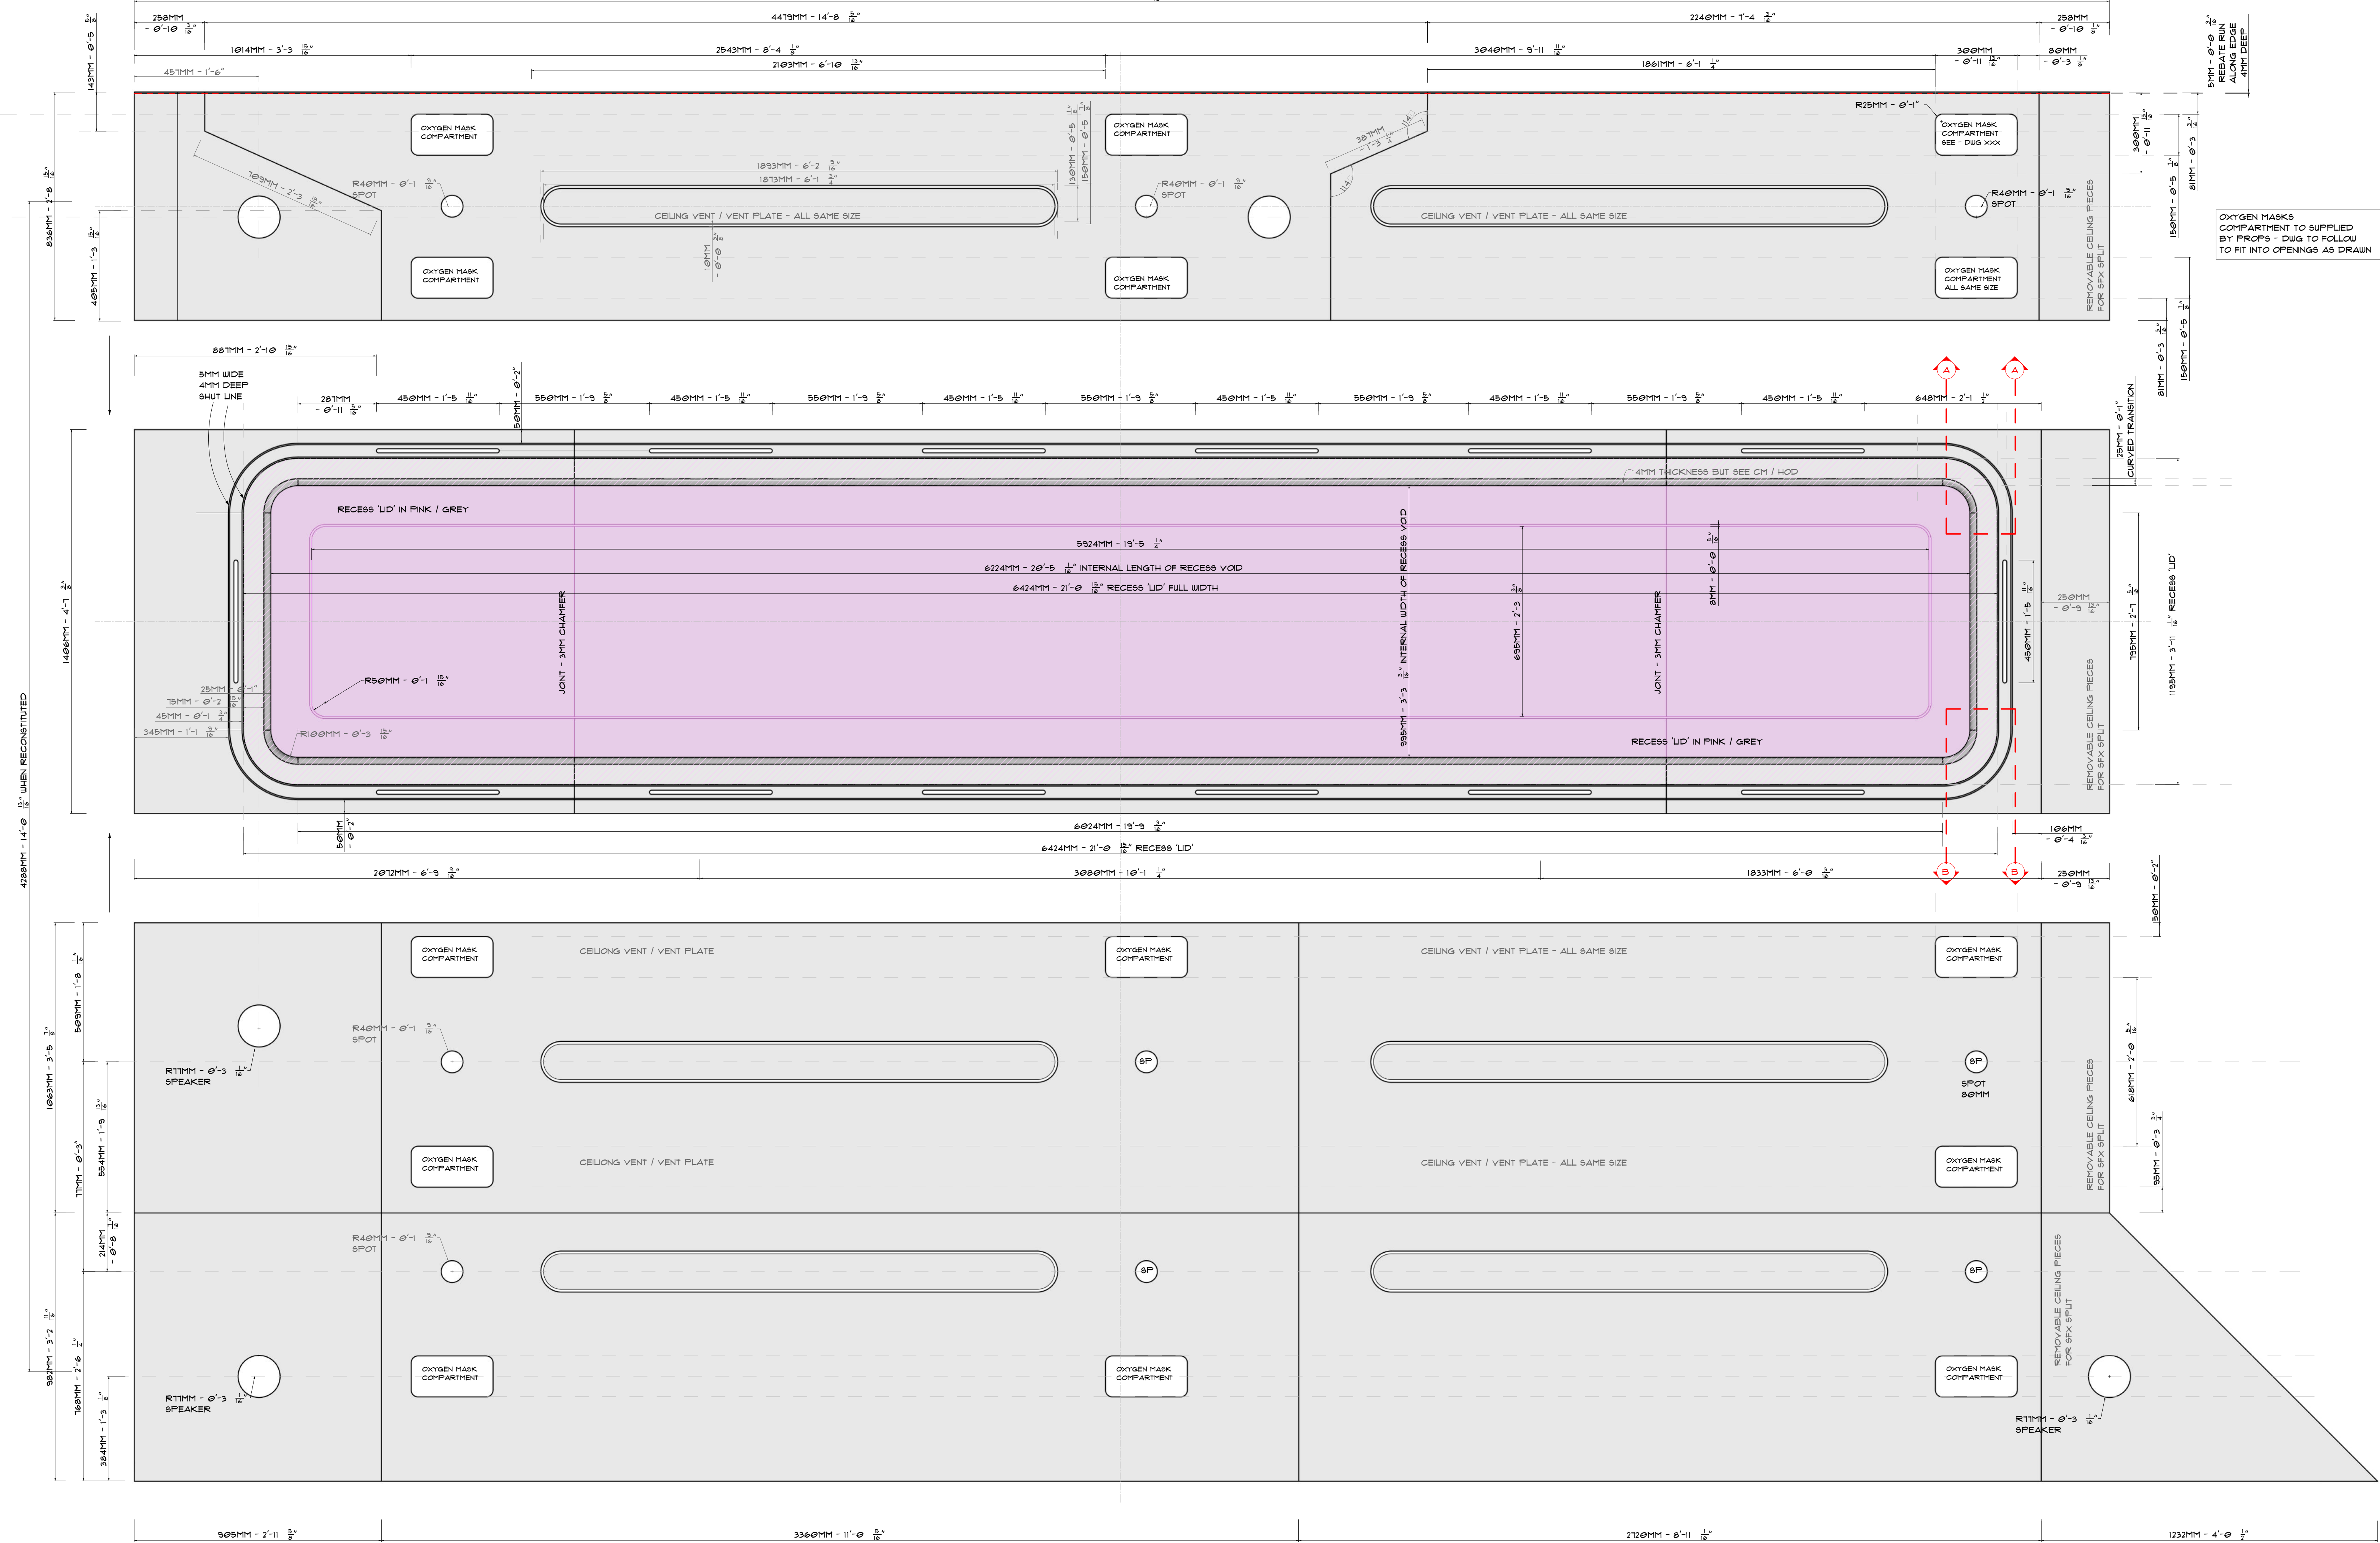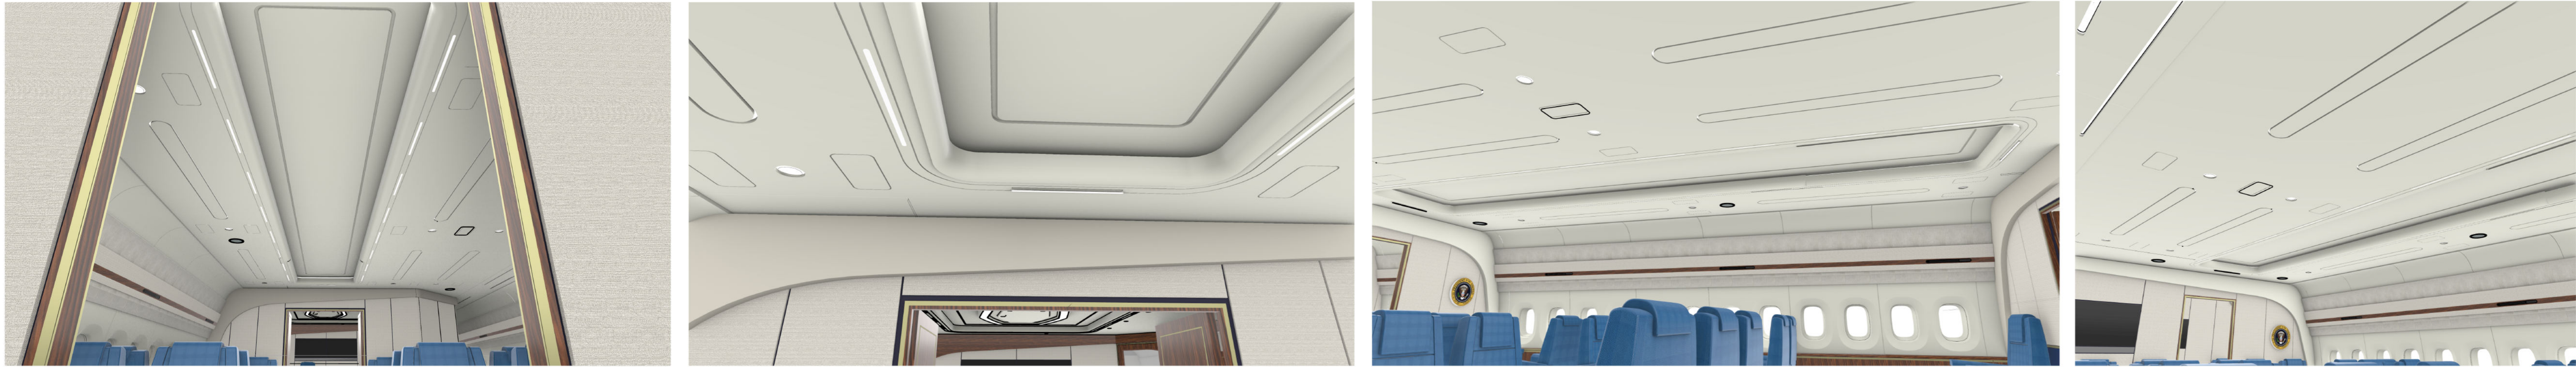


REFLECTED PLAN - CEILING SEPARATED 3 PARTS
1:10

ELEVATION CENTRE PART- 1:10

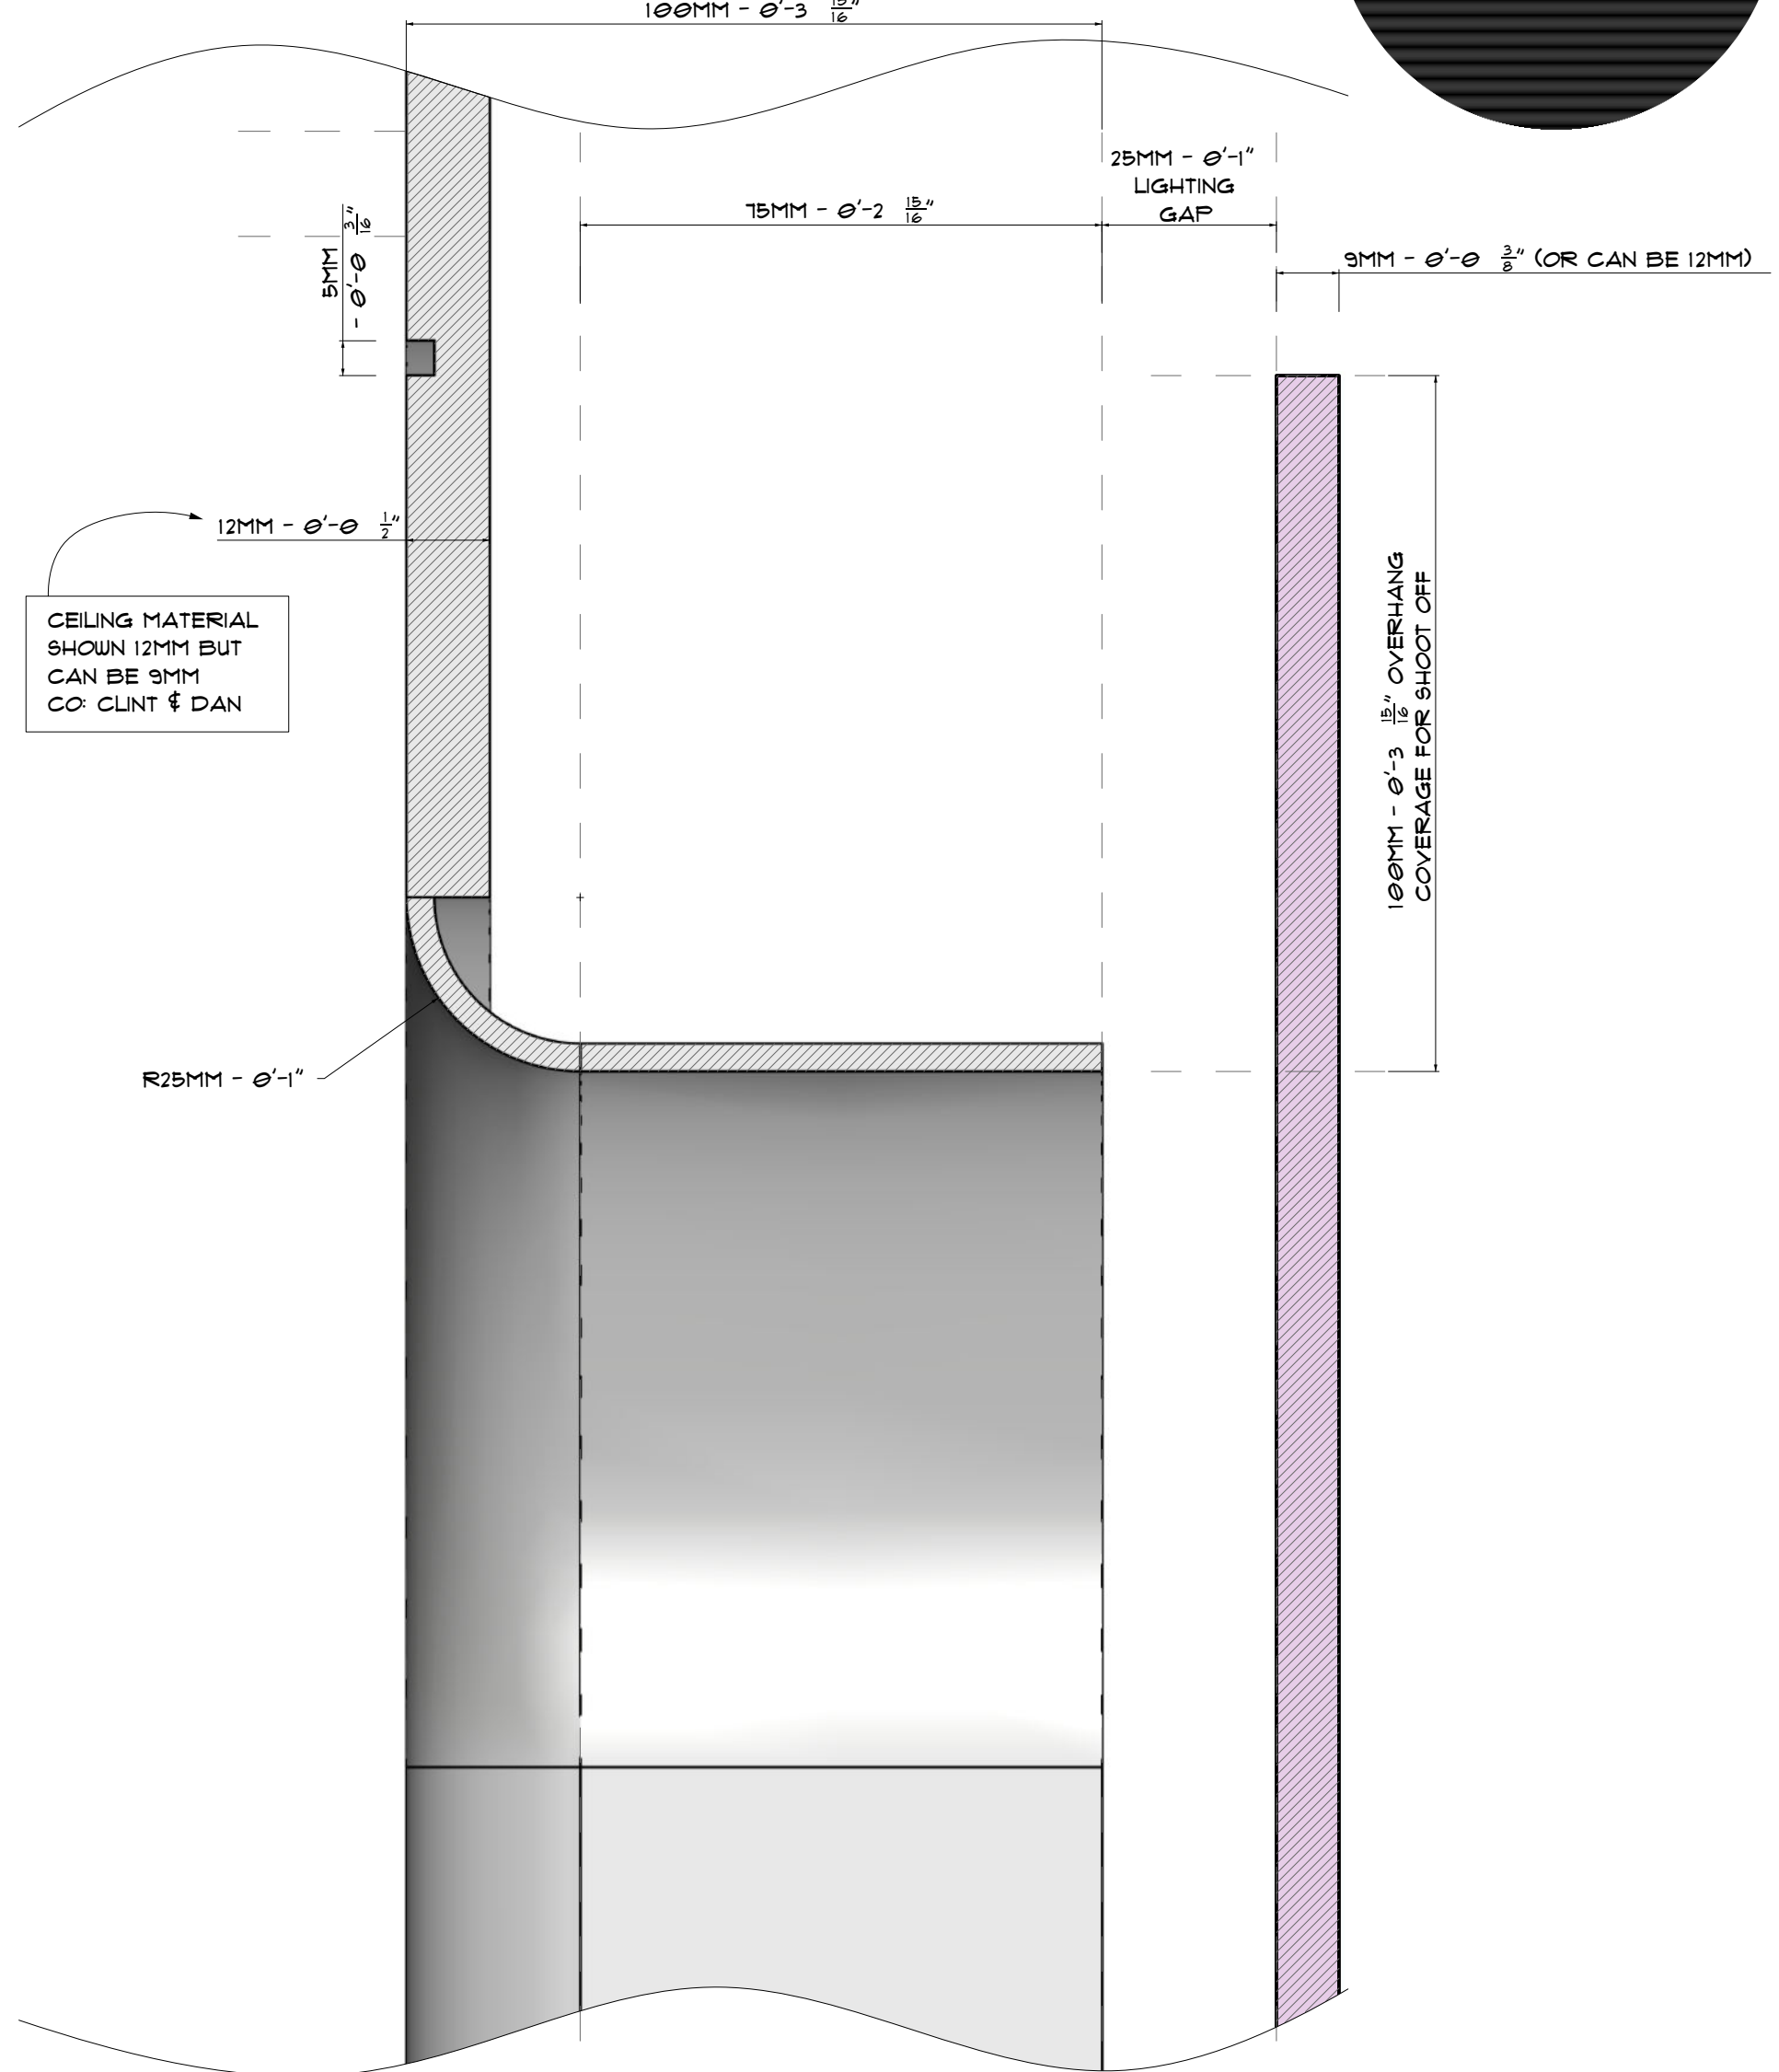

F5 SECTION VIEW - AA

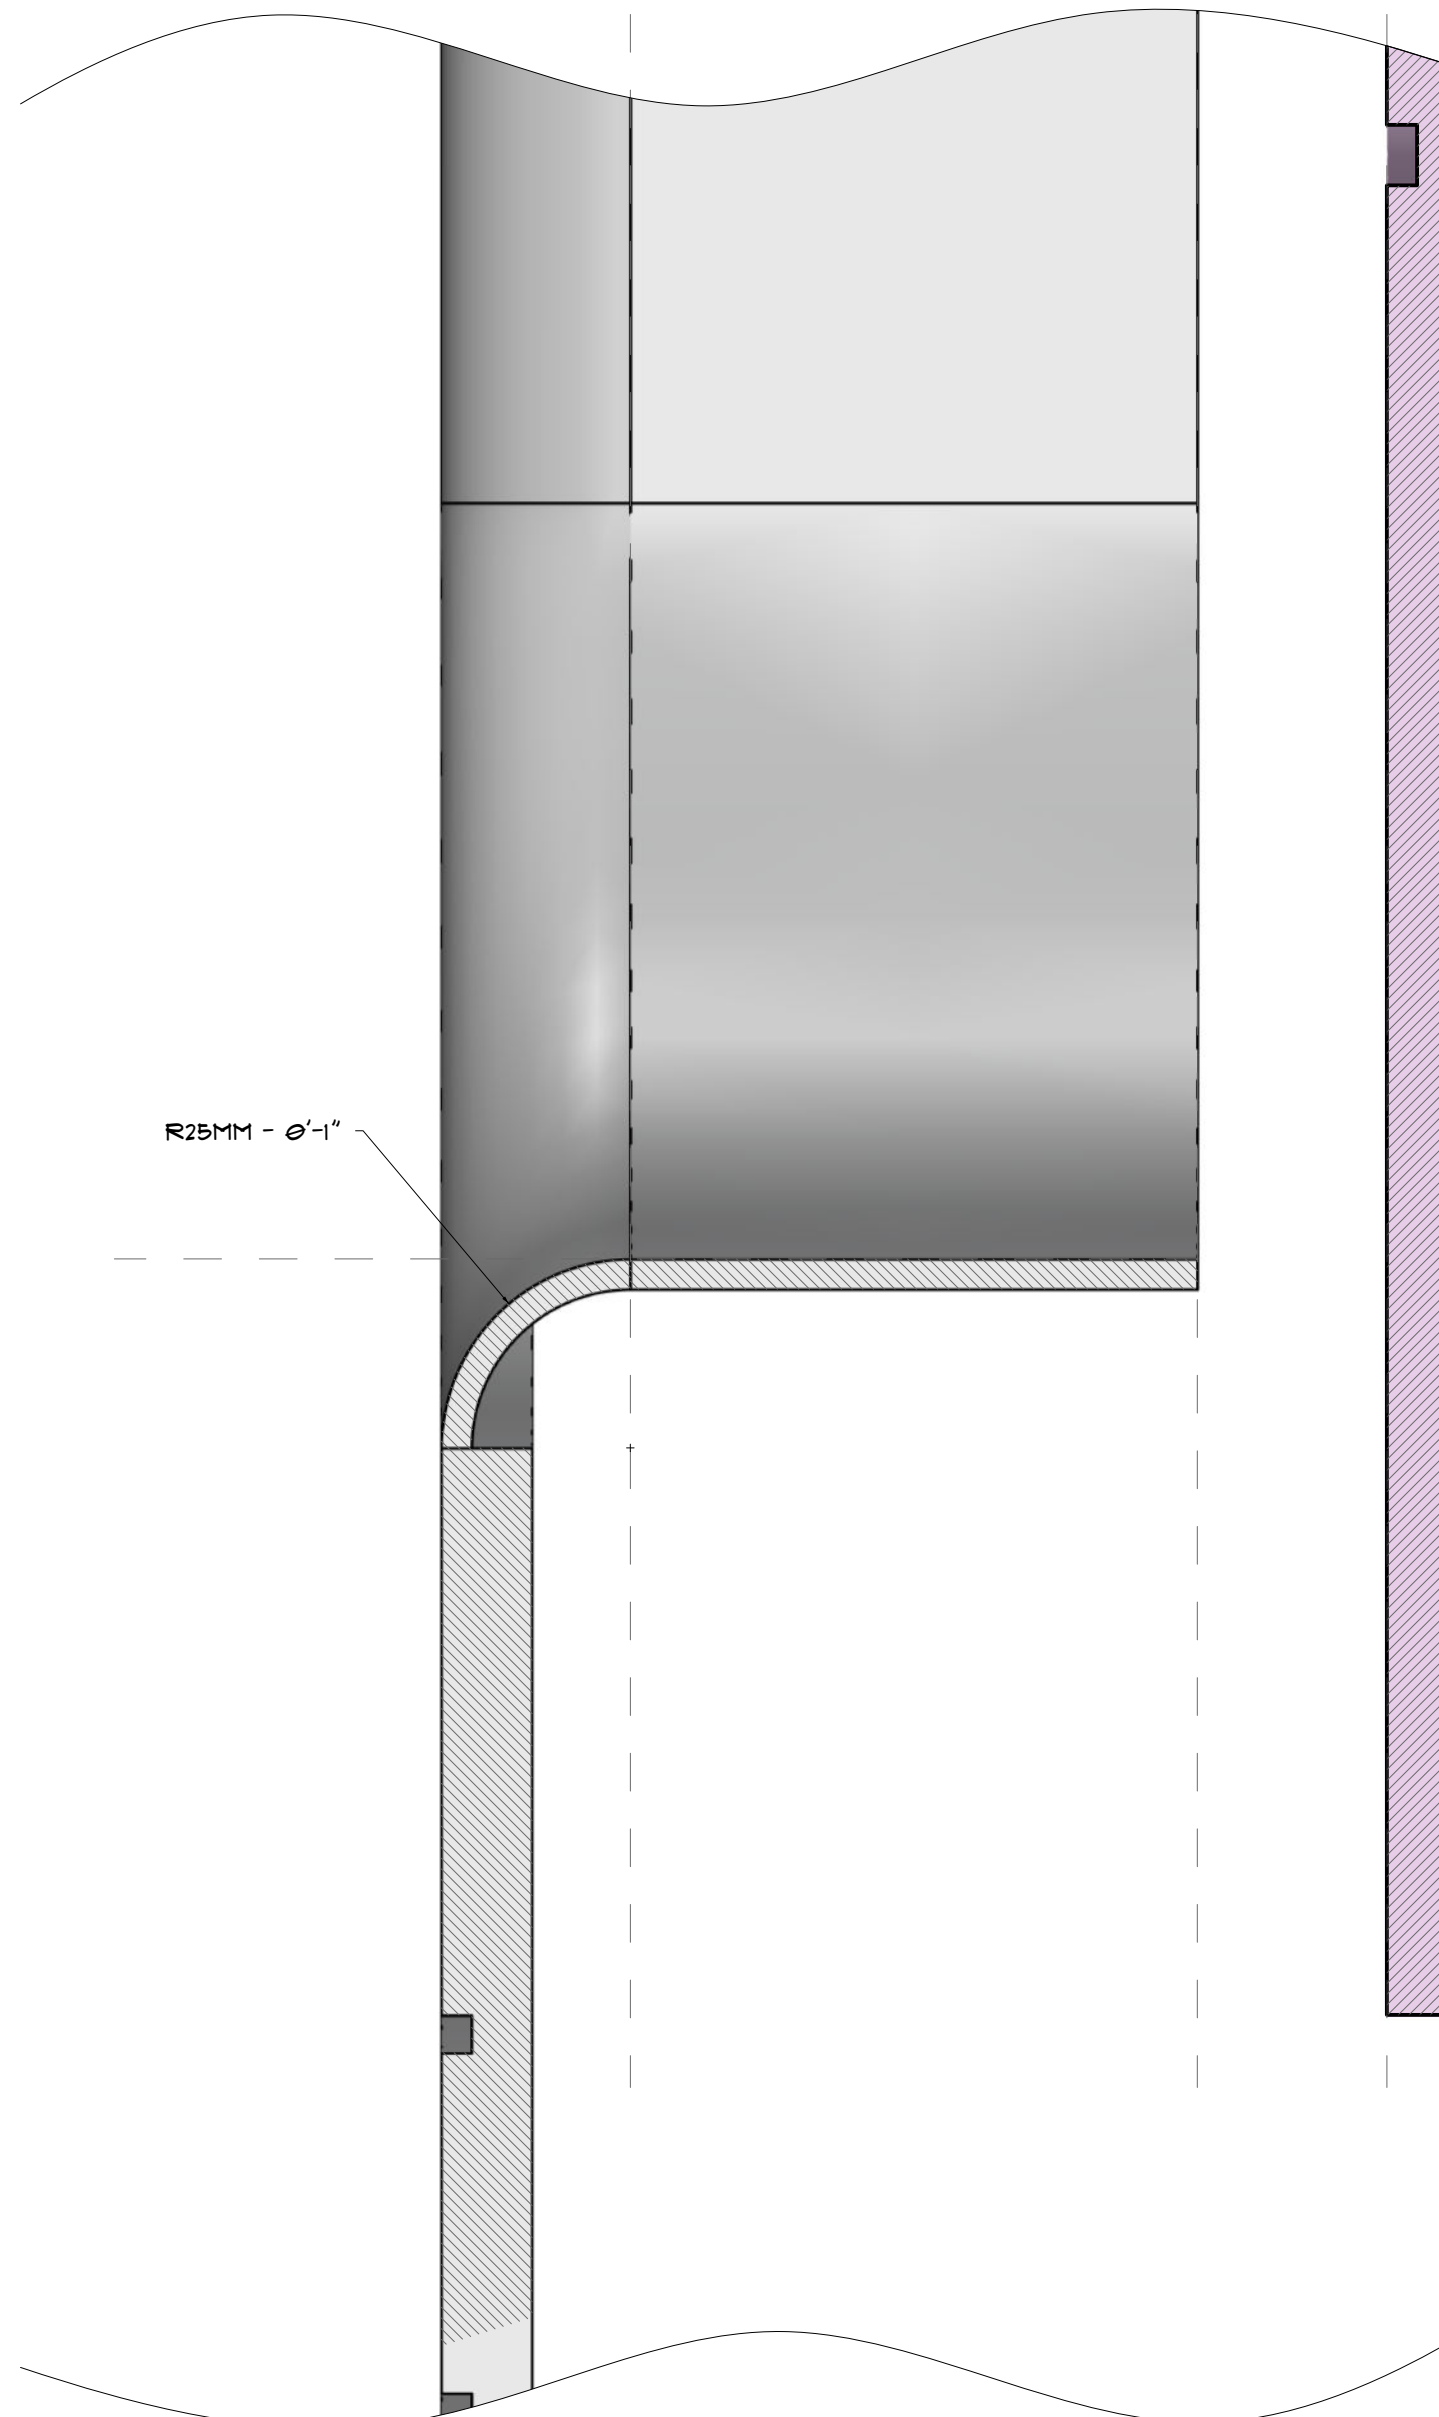

F5 SECTION VIEW - BB

READ WITH:
300-012 AFI LARGE PLAN
303-012 AFI LIGHTING PLAN (NA)
340-012 AFI HALLWAY & LONG CORRIDOR CEILING PLAN
352-012 AFI PRESIDENT'S OFFICE CEILING P&E
376-012 AFI CONFERENCE ROOM CEILING PLAN
331-012 AFI GALLEY & SECURITY 1 & SECURITY 2 CEILING PLANS
321-012 AFI PRESIDENT'S OFFICE & SECURITY 2 P&E
325-012 AFI CONFERENCE ROOM P&E
352-012 AFI STAFF OFFICE P&E

		SET: 012 - AIR PLAN CABIN LEVEL
DETAIL: HALLWAY & CORRIDOR CEILING PLAN		
DIRECTOR: LYA HANAUER		
LOCATION: STAGE: LX STAGE A	DATE: 24 / 03 / 23	SCALE: 1:50, 1:20
DRAWN BY: DU	DIRECTOR: GREENS	REVIEWED: GREENS
X: SCENE MANAGER	X: PROPS	X: PRODUCTION
X: CARPENTERS	X: PROP MAKERS	X: HEALTH & SAFETY
X: PLANTERS	X: DRUMS	X: CAMERA
X: PAINTERS	X: LIGHTING	X: STAGE HANDS
X: METAL	X: RIGGERS	X: SOUNDWOMEN
X: SCULPTORS	X: PRACTICAL SVX	X: ACTION VEHICLES
X: SET DEC	X: VFX	X: LOCATIONS
X: GRAPHICS	X: STYLING	X: SCENE ARTISTS
WPAJ APPROVAL: [Signature]	SET #	DWG #
	012	340